

DATE:

REVISIONS:

NO.	DATE	BY

Copyright (C) 2015 by Triad/Haines Associates. All Rights Reserved. This document is intended only for use on the project specified in the title block. Any reproduction or use of this document, without the consent of Triad/Haines, is prohibited.

PREPARED FOR:

NERVE FREEMAN

 804 SAN ANTONIO RD

 PALO ALTO, CA 94303

SARGENT RANCH QUARRY

 AGGREGATE PLANT

 LIGHTING PLAN

SARGENT RANCH QUARRY

AGGREGATE PLANT

LIGHTING PLAN

DATE: 12/01/2020


SCALE: AS SHOWN

DRAWN: SCR

JOB NO.: 01.4020

OWN:

FIGURE 8a

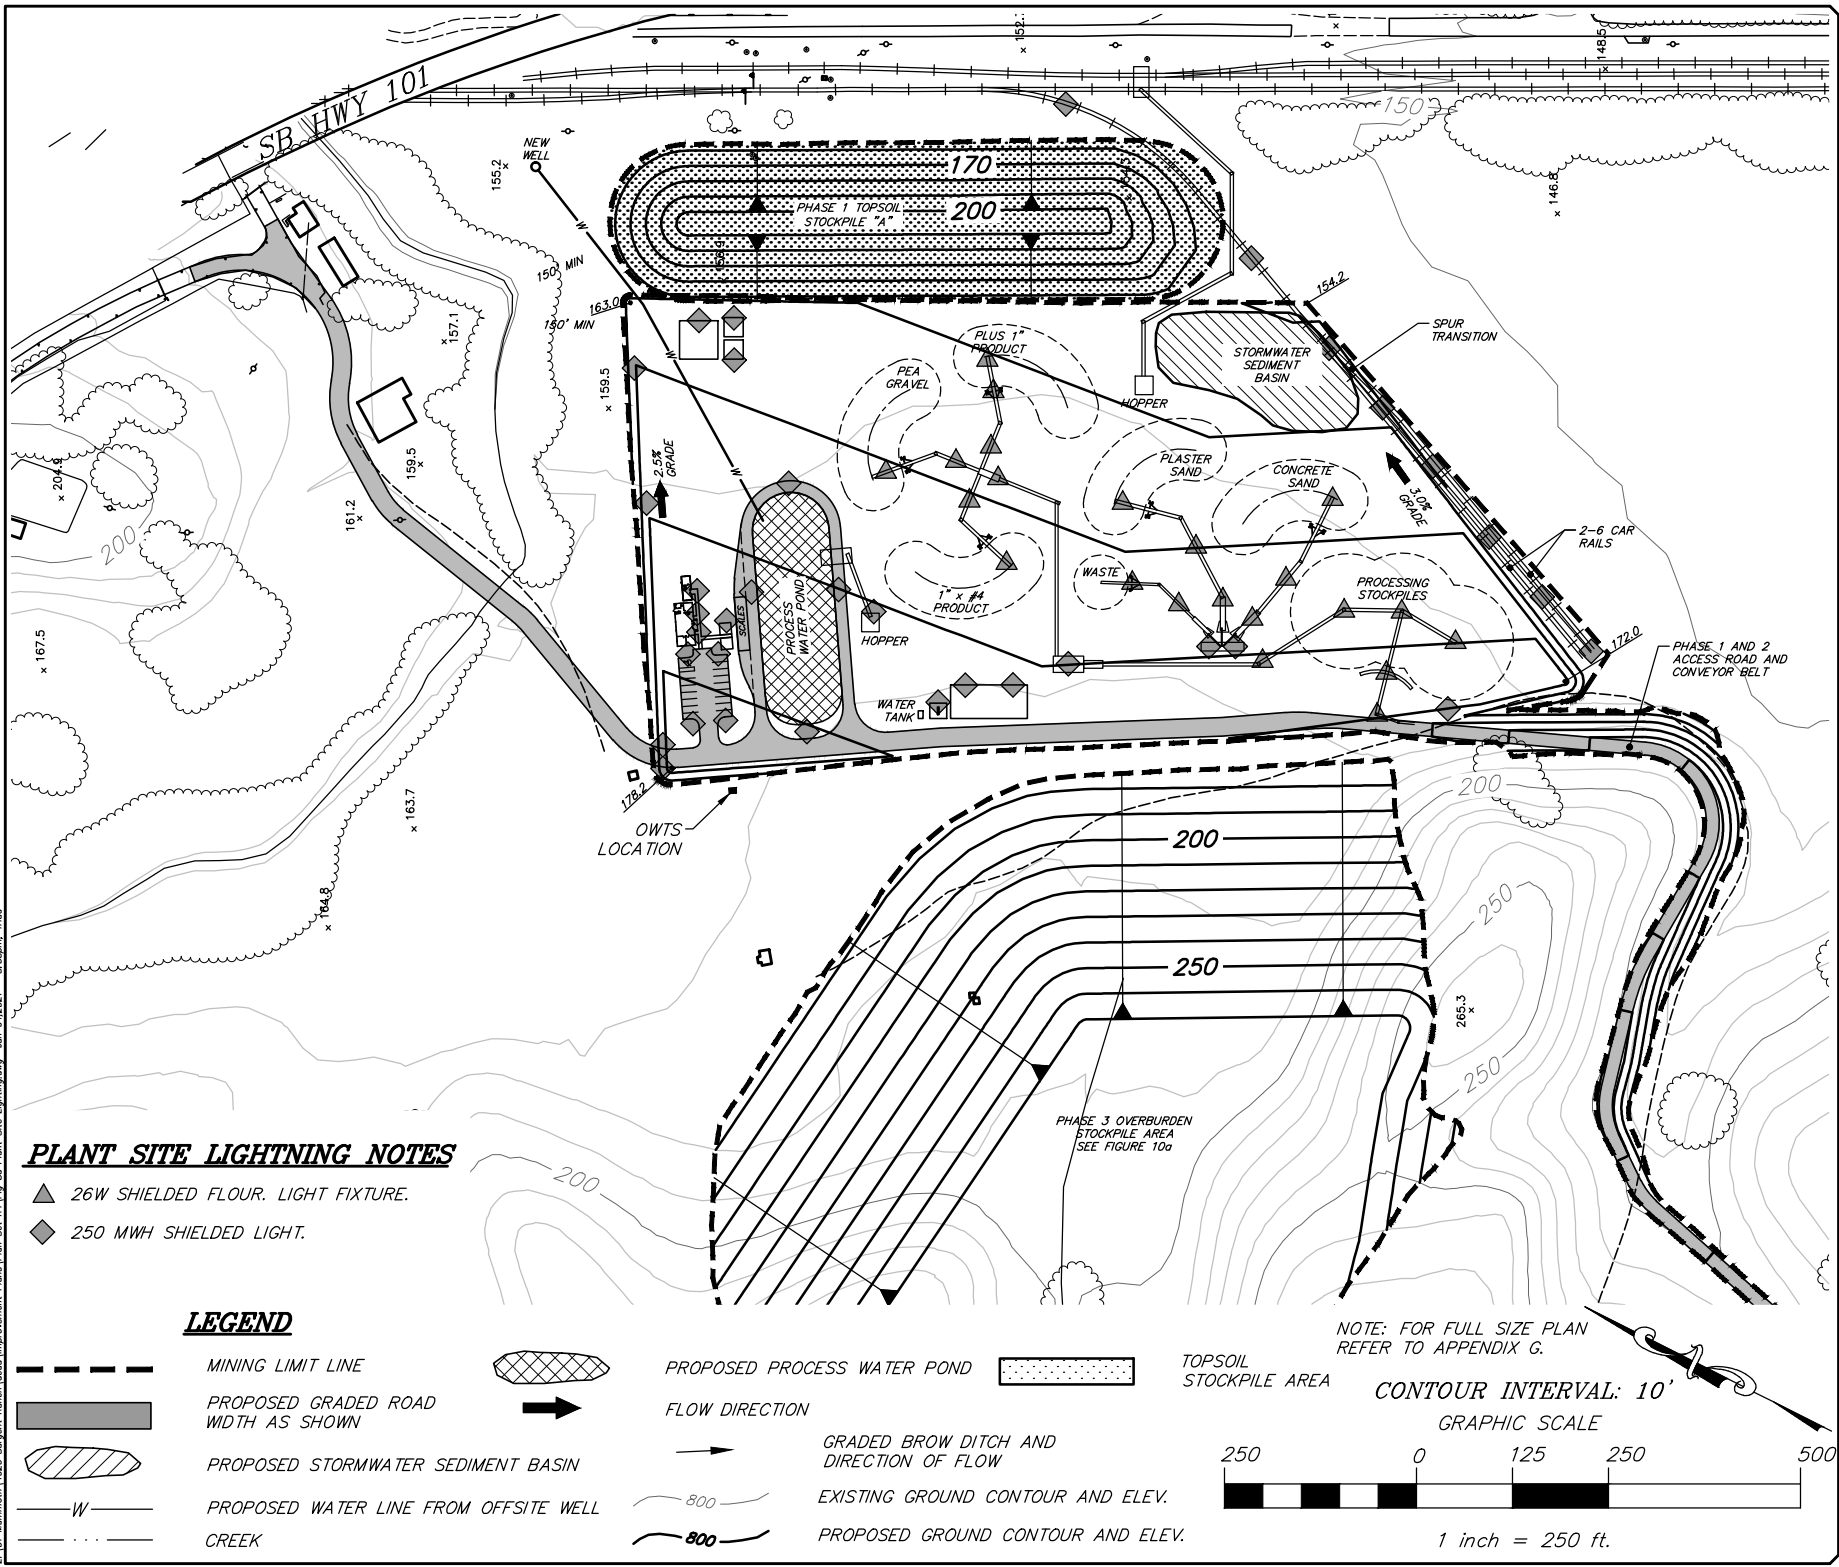

Z:\07 Mammoth\4020 Sargent Ranch\Local\Improvement Plans\Plan Set\04\Fig 8a Plant Site Lighting.dwg Jan 04/2021 - 3:55pm, Trial