

**LIGHTING SITE PLAN**  
Scale: 1 inch= 25 Ft.

Luminaire Schedule														
Symbol	Qty	Label	Arrangement	Lum. Watts	Lum. Lumens	LLD	LDD	BF	LLF	BUG Rating	[MANUFAC]	Description	Tag	Filename
→	4	P3-6	Single	45.8	6302	0.900	1.000	1.000	0.900	B1-U0-G1	Industrial Lighting Products Inc	SAS-6L-U-30-T3		SAS-6L-U-30-T3.ies
→	6	P4-6	Single	45.8	6234	0.900	1.000	1.000	0.900	B1-U0-G1	Industrial Lighting Products Inc	SAS-6L-U-30-T4		SAS-6L-U-30-T4.ies
→	4	P4-6-HSS	Single	45.8	4081	0.900	1.000	1.000	0.900	B1-U0-G1	Industrial Lighting Products Inc	SAS-6L-U-30-T4-HSS		SAS-6L-U-30-T4-HSS.ies
→	20	P4-15-HSS	Single	108.1	10337	0.900	1.000	1.000	0.900	B1-U0-G2	Industrial Lighting Products Inc	SAS-15L-U-30-T4-HSS		SAS-15L-U-30-T4-HSS.ies
→	8	P5-15	Single	108.1	16070	0.900	1.000	1.000	0.900	B4-U0-G2	Industrial Lighting Products Inc	SAS-15L-U-30-T5S		SAS-15L-U-30-T5S.ies
↑	42	W3	Single	26	2273	0.900	1.000	1.000	0.900	B1-U0-G1	Performance IN Lighting	071206	TOP OF FIXTURE AT 8.5 FT	PIL_MIMIK_20_M_730_071206.ies
↑	47	W4	Single	26	2149	0.900	1.000	1.000	0.900	B1-U0-G0	Performance IN Lighting	071208	TOP OF FIXTURE OF 8.5 FT	PIL_MIMIK_20_M_730_071208.ies

Calculation Summary							
Label	CalcType	Units	Avg	Max	Min	Avg/Min	Max/Min
INTERIOR MAIN BLDG CORRIDOR	Illuminance	Fc	2.2	8.6	0.6	3.63	14.33
PATH	Illuminance	Fc	2.9	12.6	1.0	2.88	12.60
SITE	Illuminance	Fc	1.6	7.9	0.5	3.10	15.80

**LIGHTING NOTES:**  
ALL LIGHTS ARE AT FULL OUTPUT & 3K


**OVERALL PHOTOMETRIC SITE PLAN**  
**SAN MARTIN STORAGE**  
12625 MONTEREY RD.  
SAN MARTIN, CA 95046

All values shown are maintained horizontal footcandle at grade level.  
The lighting calculations provided in this report approximate the light levels expected within the space as defined and are based on the information provided to Cal Lighting. Please verify the data to assure the accuracy of the report. Cal Lighting is not responsible for light output of lamps and ballasts, or design variables.

#	Date	Comments

Drawn By: CL/C  
Checked By: R  
Scale: AS SHOWN


SAN MARTIN STORAGE  
12625 MONTEREY RD.  
SAN MARTIN, CA 95046

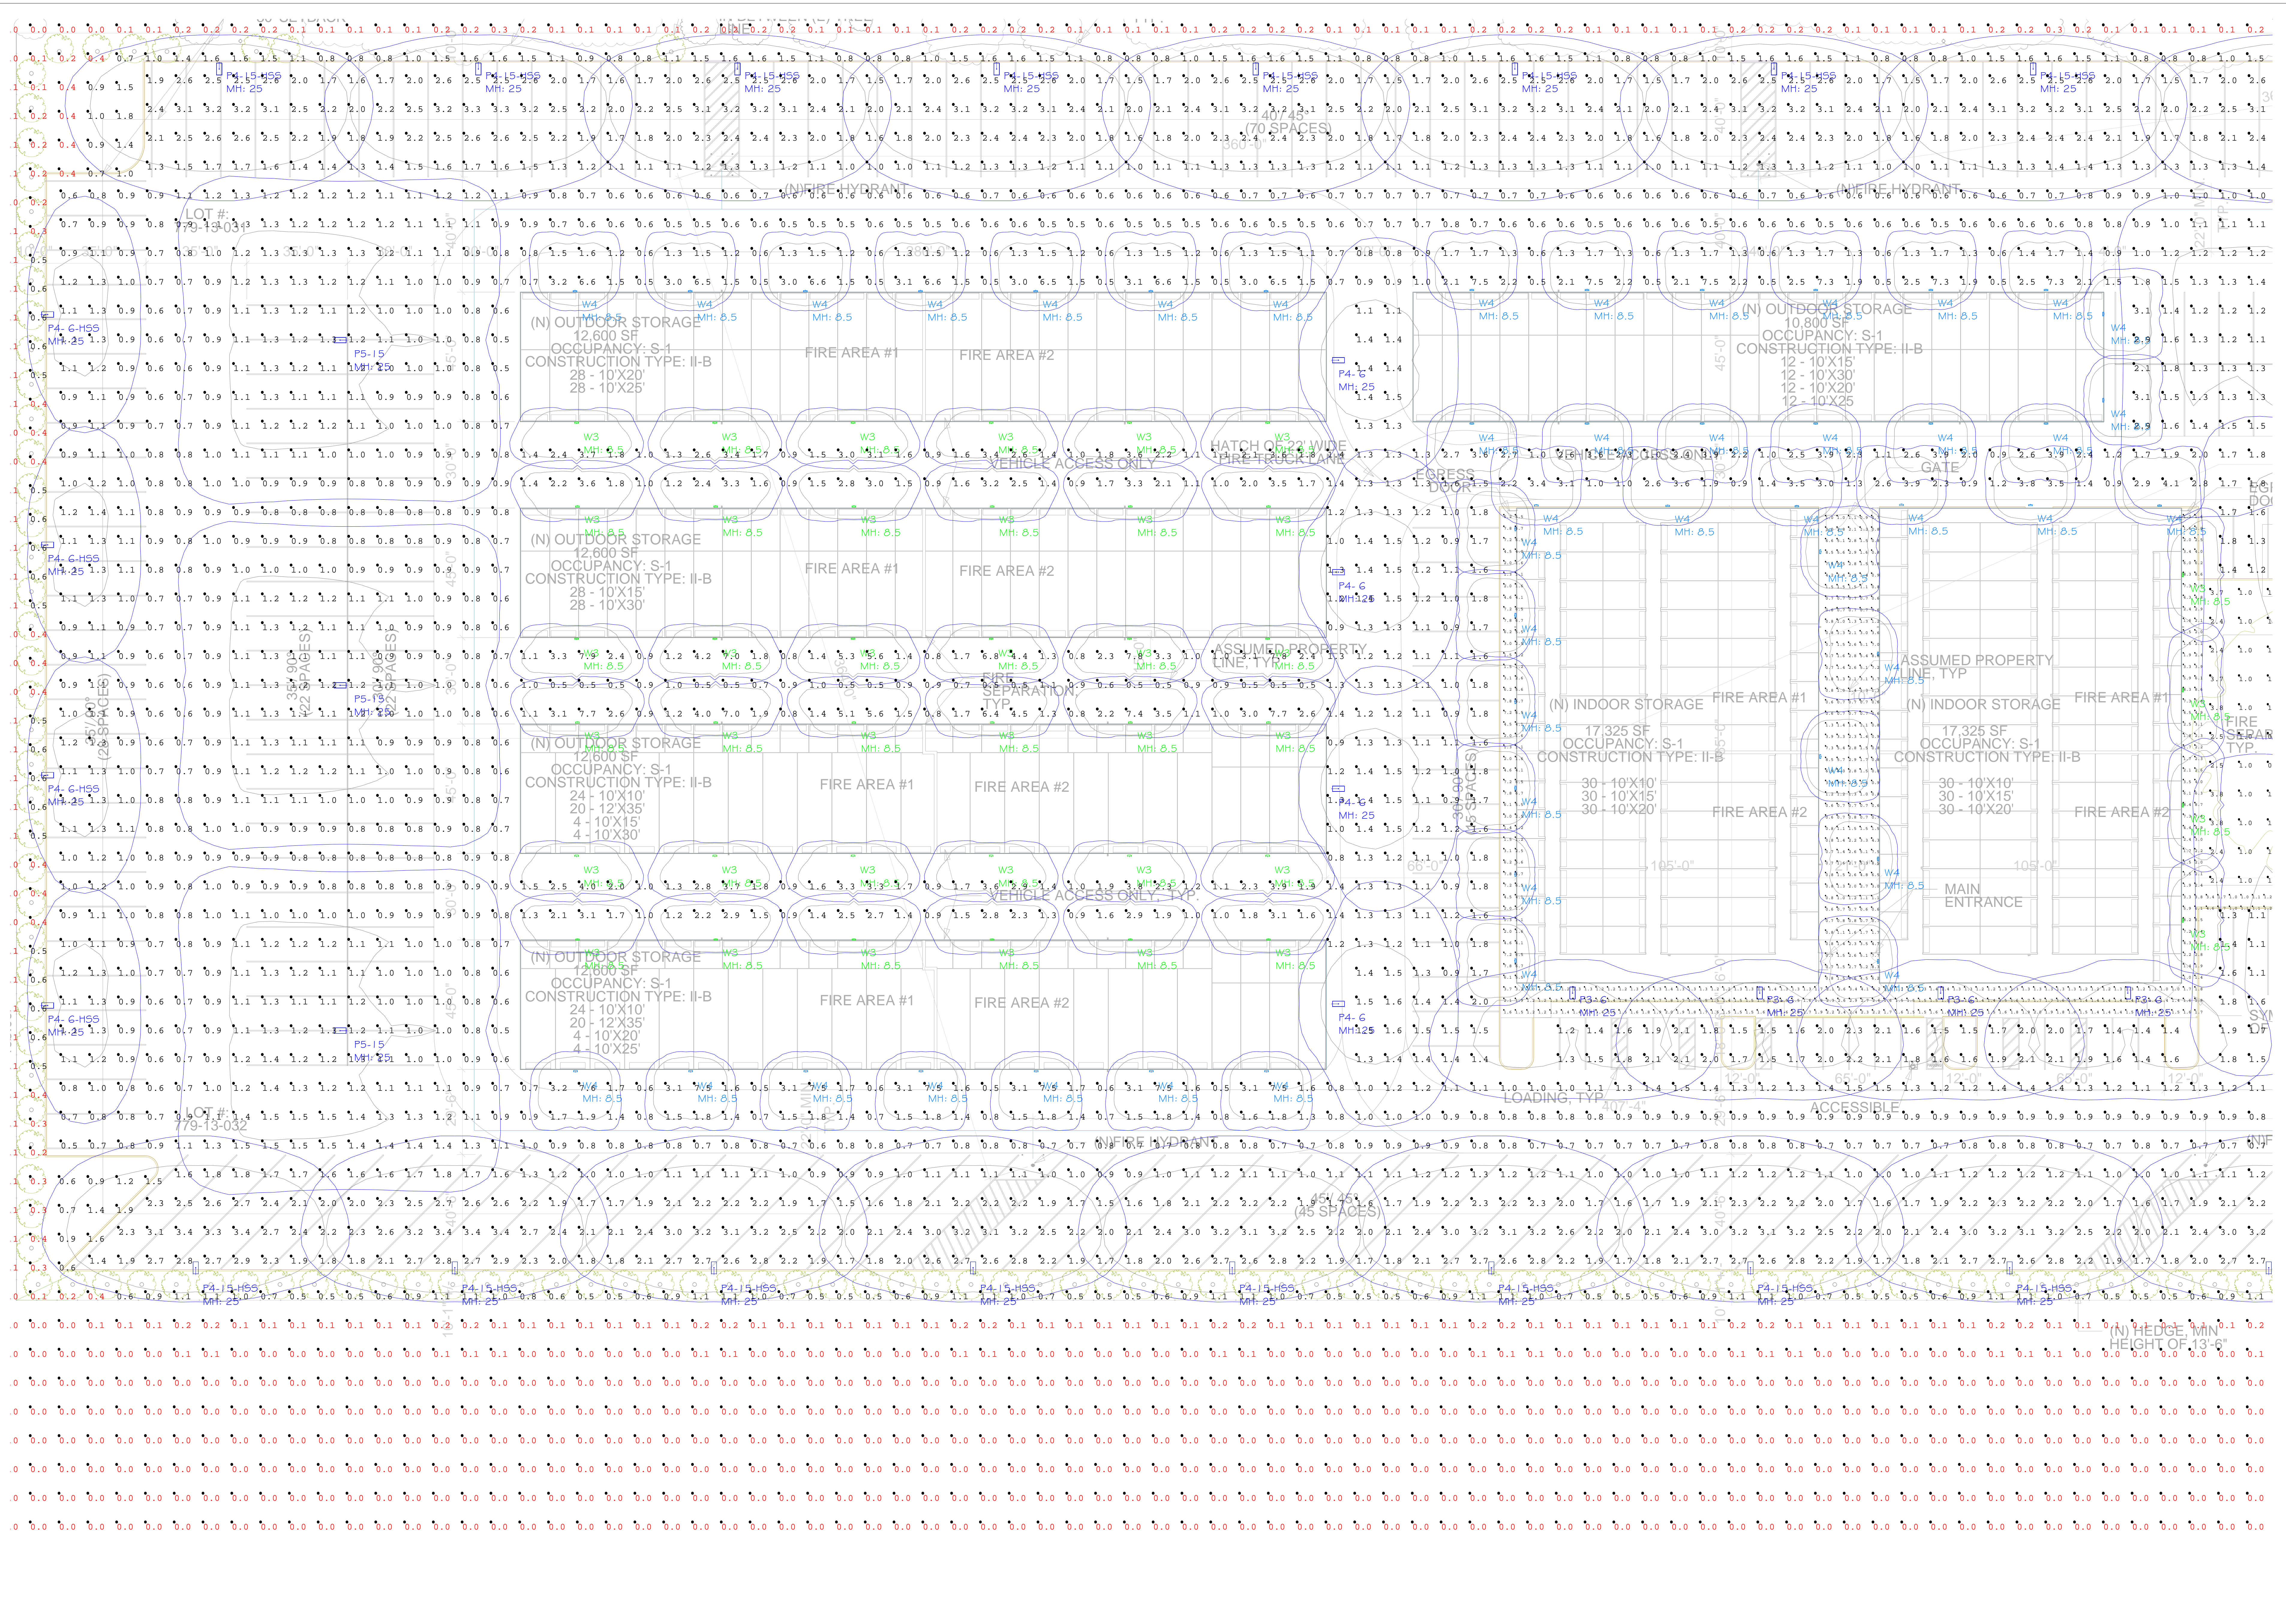

PARTIAL PHOTOMETRIC SITE PLAN  
Scale: 1 inch= 20 Ft.

#	Date	Comments

Revisions

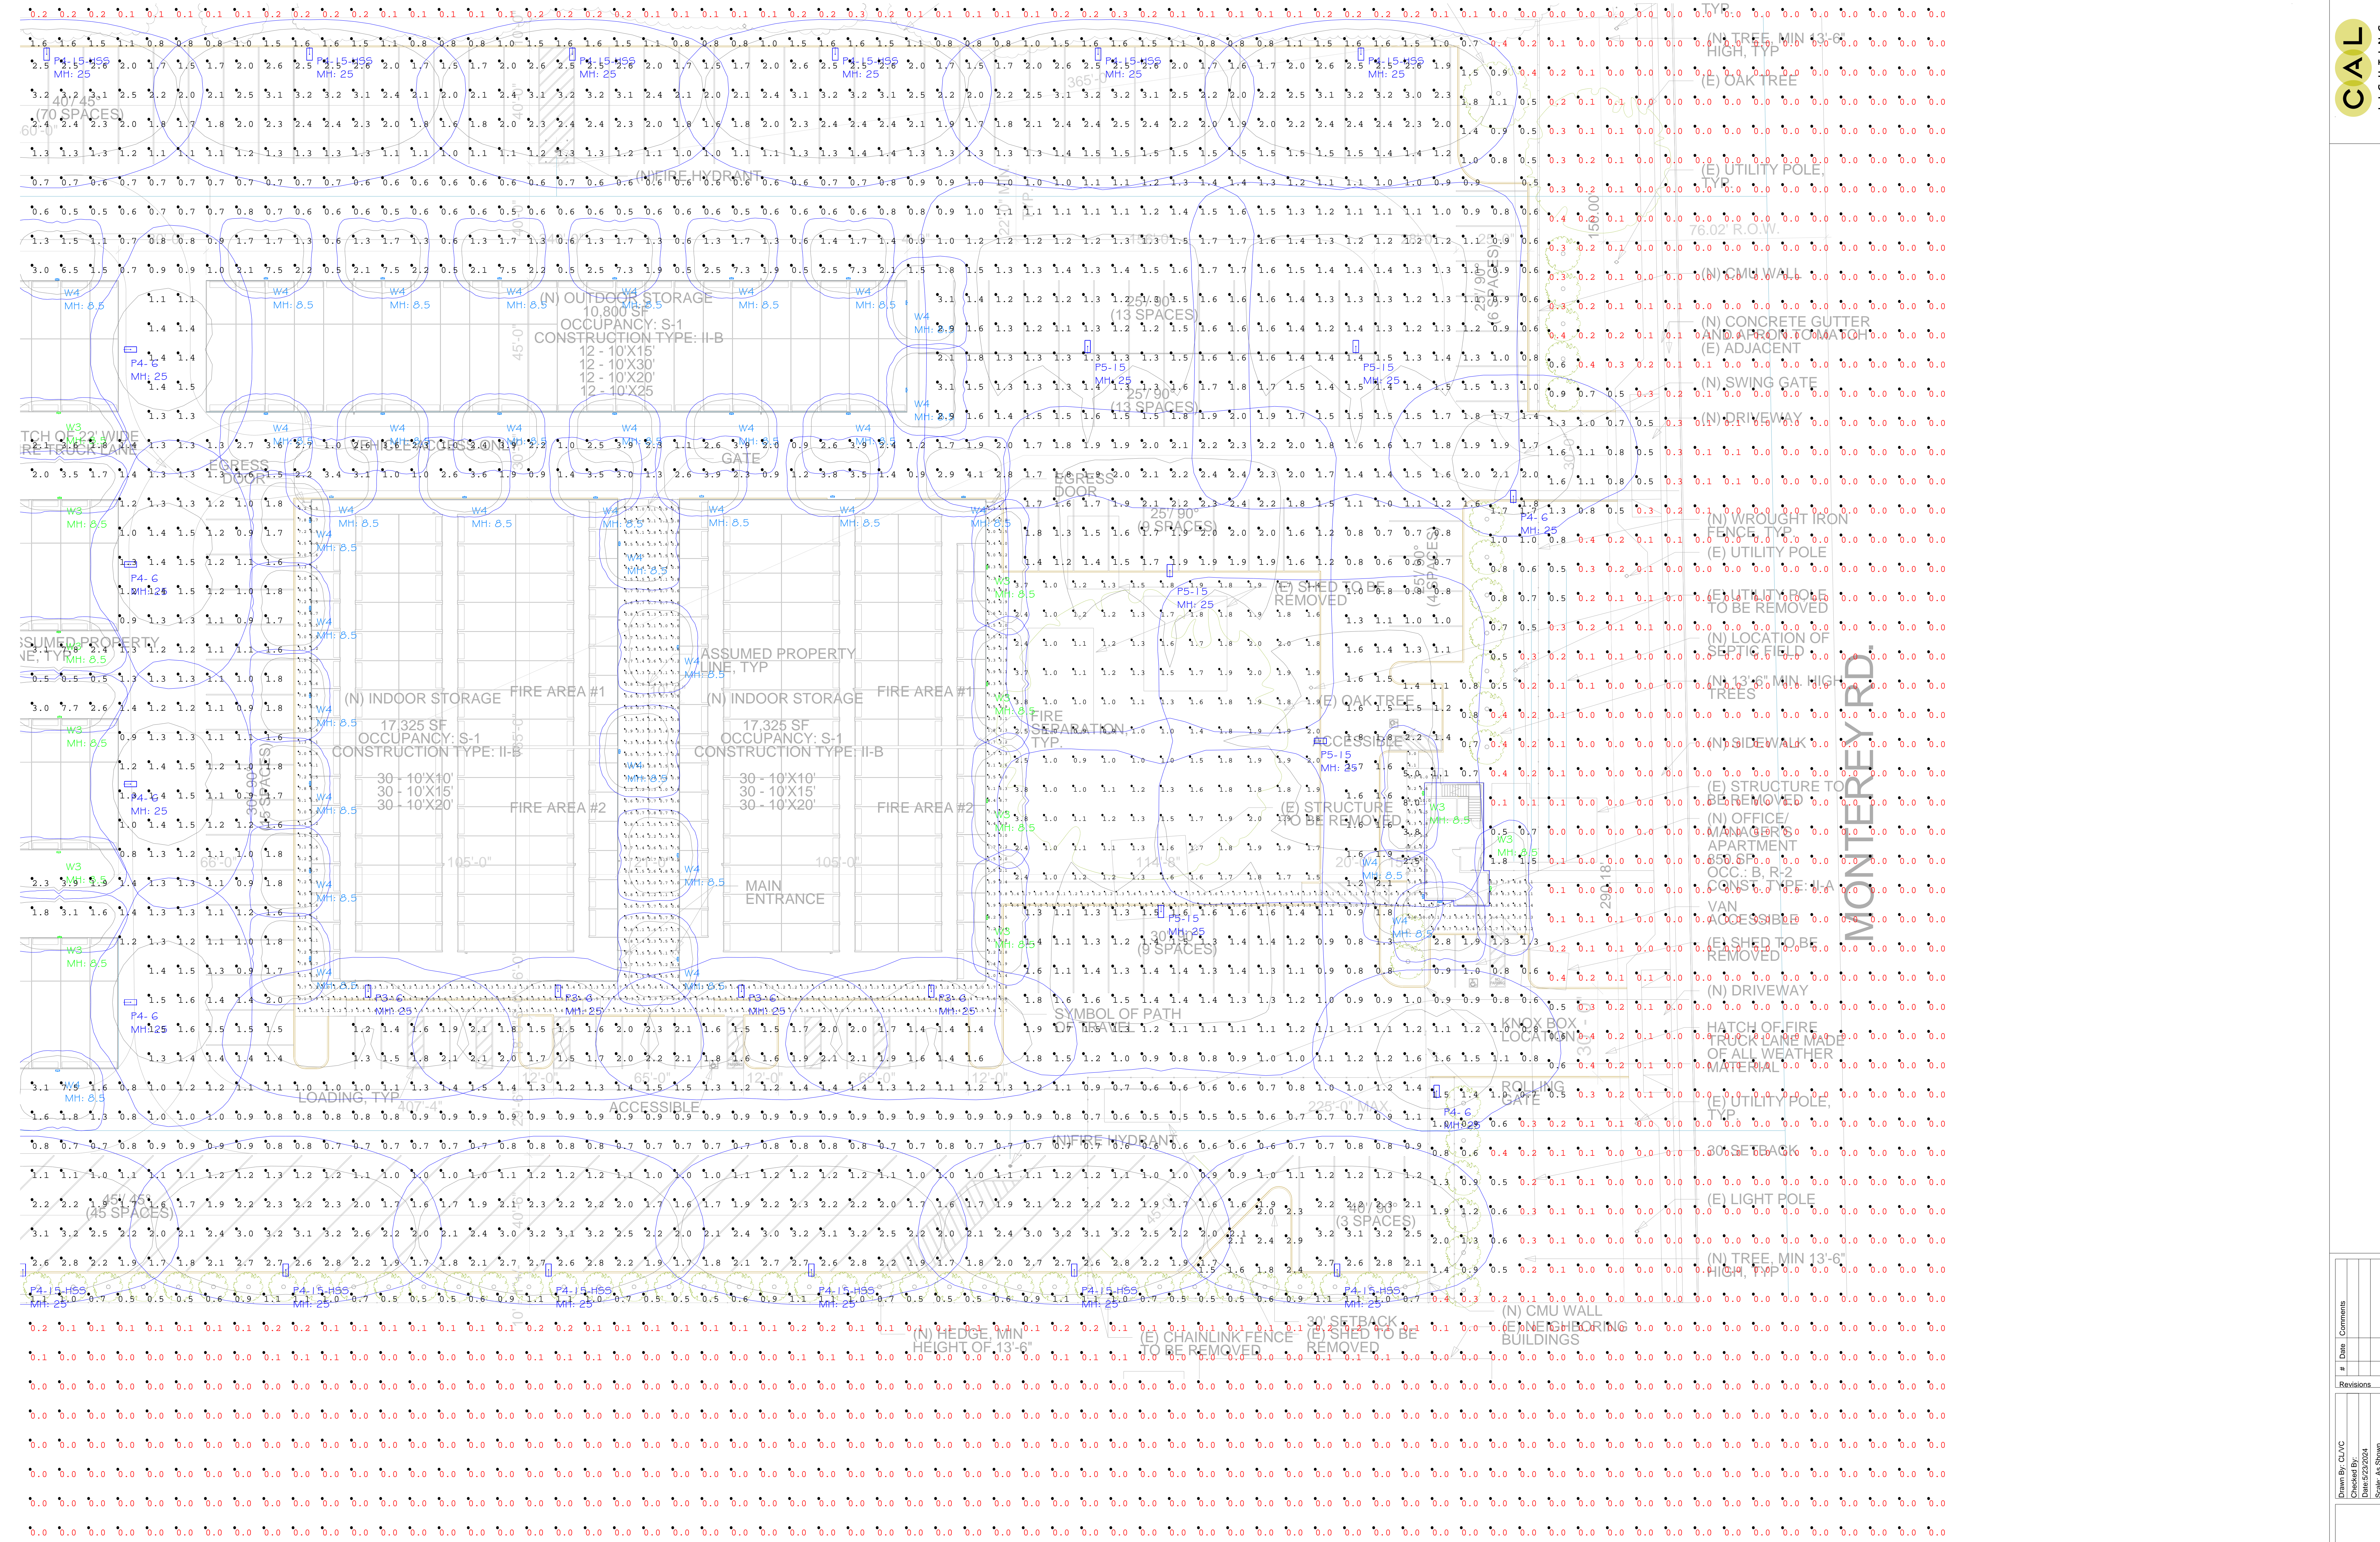

PARTIAL PHOTOMETRIC SITE PLAN  
Scale: 1 inch = 20 Ft.

#	Date	Comments

Drawn By: CLVC  
 Checked By: Bence Szozda  
 SAN MARTIN STORAGE  
 1525 MONTEREY RD.  
 SAN MARTIN, CA 94068